


12'-1" [3682.99] FINISHED OPENING

11'-11 $\frac{3}{4}$ " [3651.25] SKYCEILING

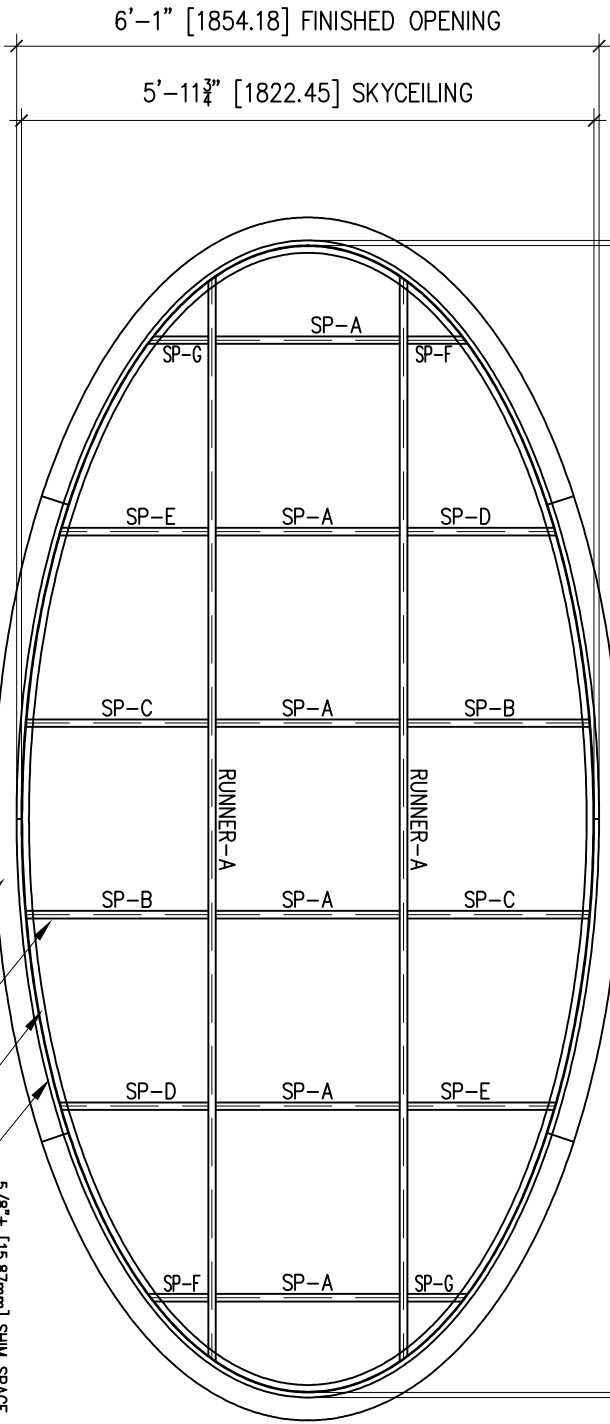

• THIS DRAWING IS FOR GENERAL REFERENCE ONLY.

• IT IS A SAMPLE OF A TYPICAL SKYCEILING AND IS TO BE USED IN CONJUNCTION WITH AN APPROPRIATE CROSS-SECTION DRAWING (XS1).

• FOR SPECIFIC GRID PLAN AND LIGHTING PLAN DRAWINGS AND A CUSTOMIZED QUOTE, PLEASE CALL THE SKY FACTORY AT 1-866-759-3228 AND ASK FOR A SKY DESIGNER.

NOTE:  
VIEW SHOWN IS AS REFLECTED CEILING PLAN  
LOOKING FROM ABOVE GRID

5/8"± [15.87mm] SHIM SPACE  
CONTRACTOR TO INSTALL

15/16" [23.81mm] PERIMETER GRID  
SUPPLIED BY THE SKY FACTORY  
CONTRACTOR TO CUT AND INSTALL

15/16" [23.81mm] T-GRID  
SUPPLIED BY THE SKY FACTORY  
PRECUT TO LENGTH  
CONTRACTOR TO INSTALL

FRAMING PLATE  
SUPPLIED BY THE SKY FACTORY  
CONTRACTOR TO INSTALL

SOFFIT  
NOT PROVIDED BY THE SKY FACTORY



PO BOX 1177  
Fairfield, Iowa 52556  
Phone: 641-472-1747  
www.TheSkyFactory.com

PRODUCT

# ELLIPTICAL 6' X 12' LUMINOUS SKYCEILING GRID PLAN

## REVISIONS

DRAWN BY	OV	DATE CREATED	COMMENTS
		09-22-10	

WB1

SHEET

